


WRO1-1123456717-1002001


GROUND FLOOR

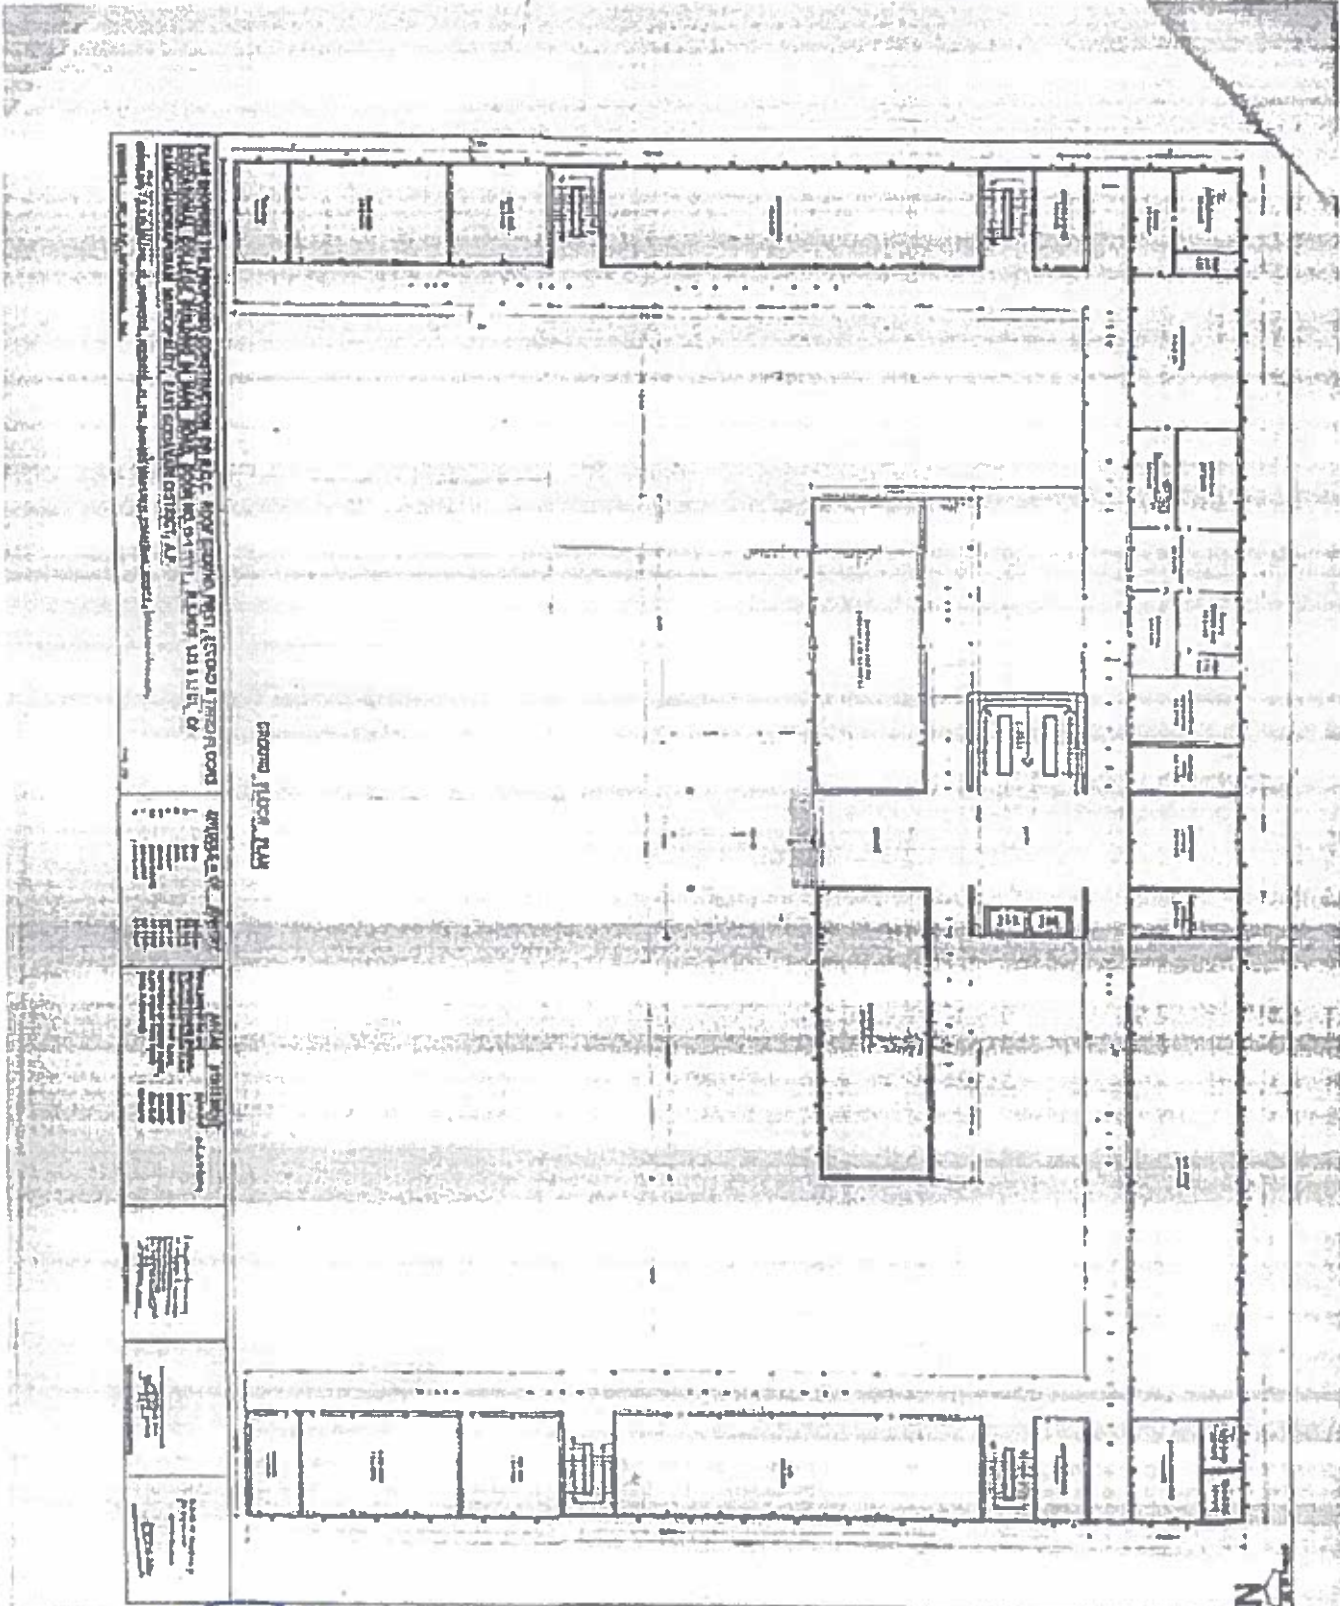

Bm
PRINCIPAL
V.S.M. COLLEGE OF ENGINEERING
RAMACHANDRAPURAM

1002001-17043711-10RM

FIRST FLOOR

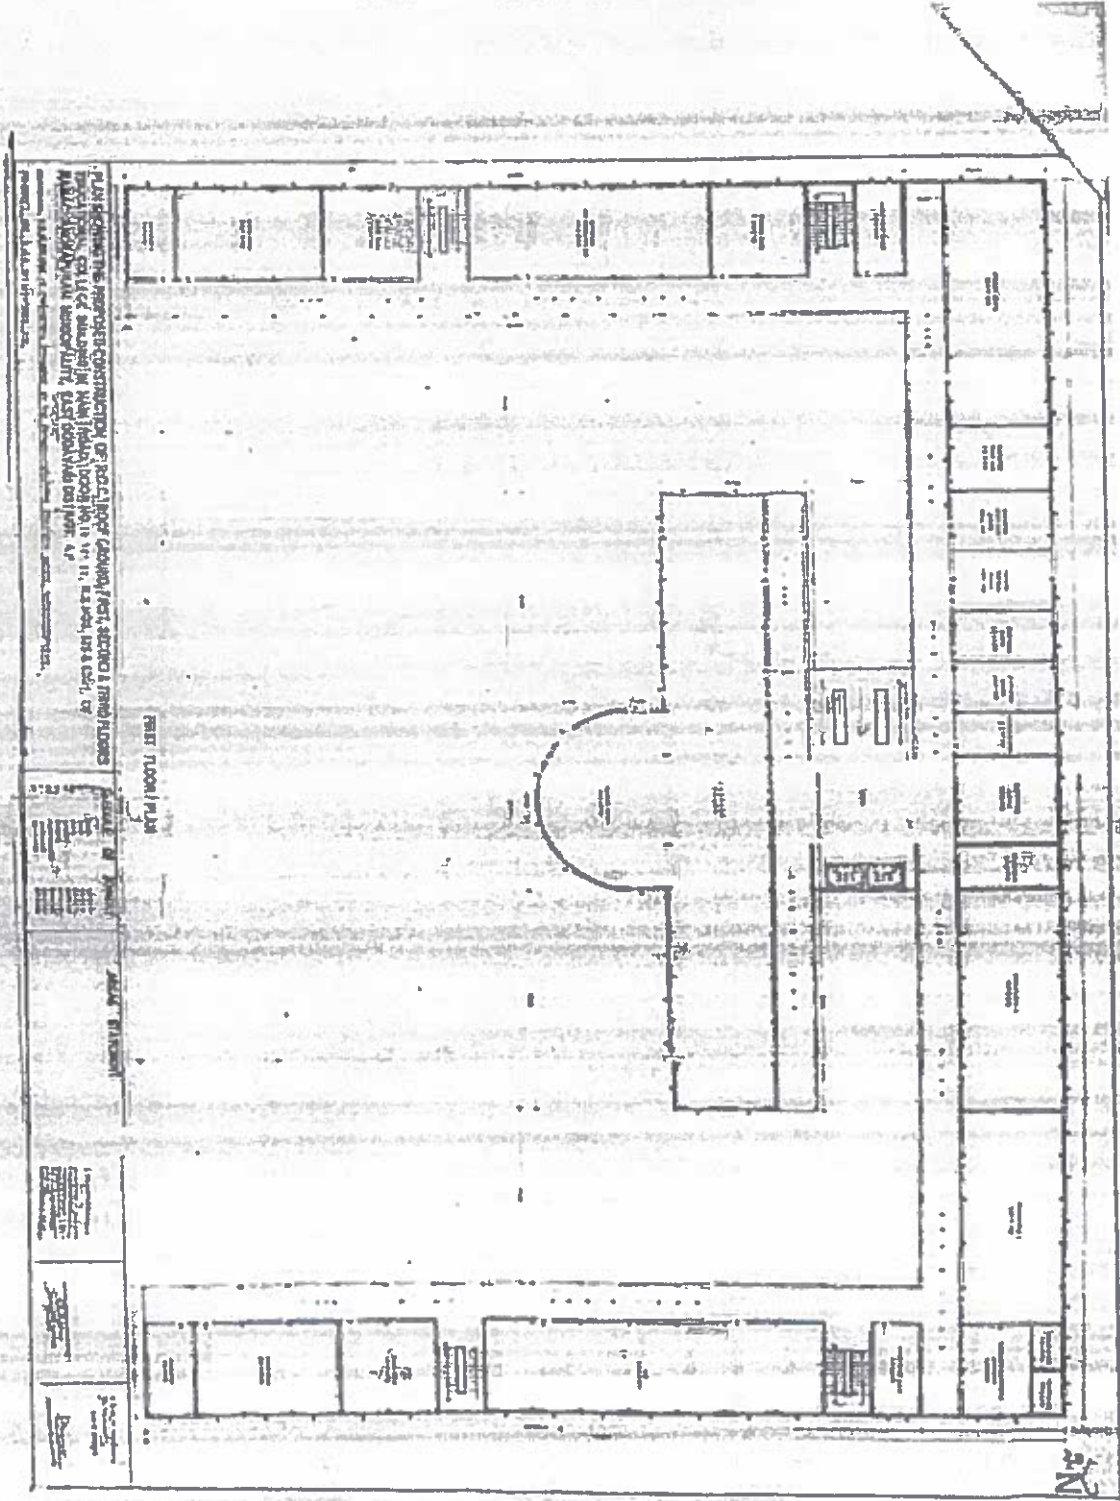

PLAN SHOWING THE PROPOSED CONSTRUCTION OF BUILDING (GENERAL FLOOR PLAN) AND THE PROPOSED LOCATION OF THE BUILDING IN THE CITY OF RAMACHANDRAPURAM, DISTRICT OF NELLORE, AP.

Scale: 1:1000

DATE: 10/10/2017



PROJECT: V.S.M. COLLEGE OF ENGINEERING



for
 PRINCIPAL
 V.S.M. COLLEGE OF ENGINEERING

WK01-1125456-17.1002001

THIRD FLOOR

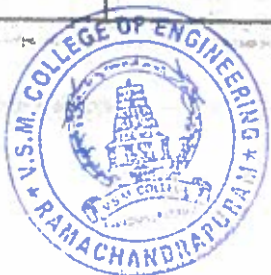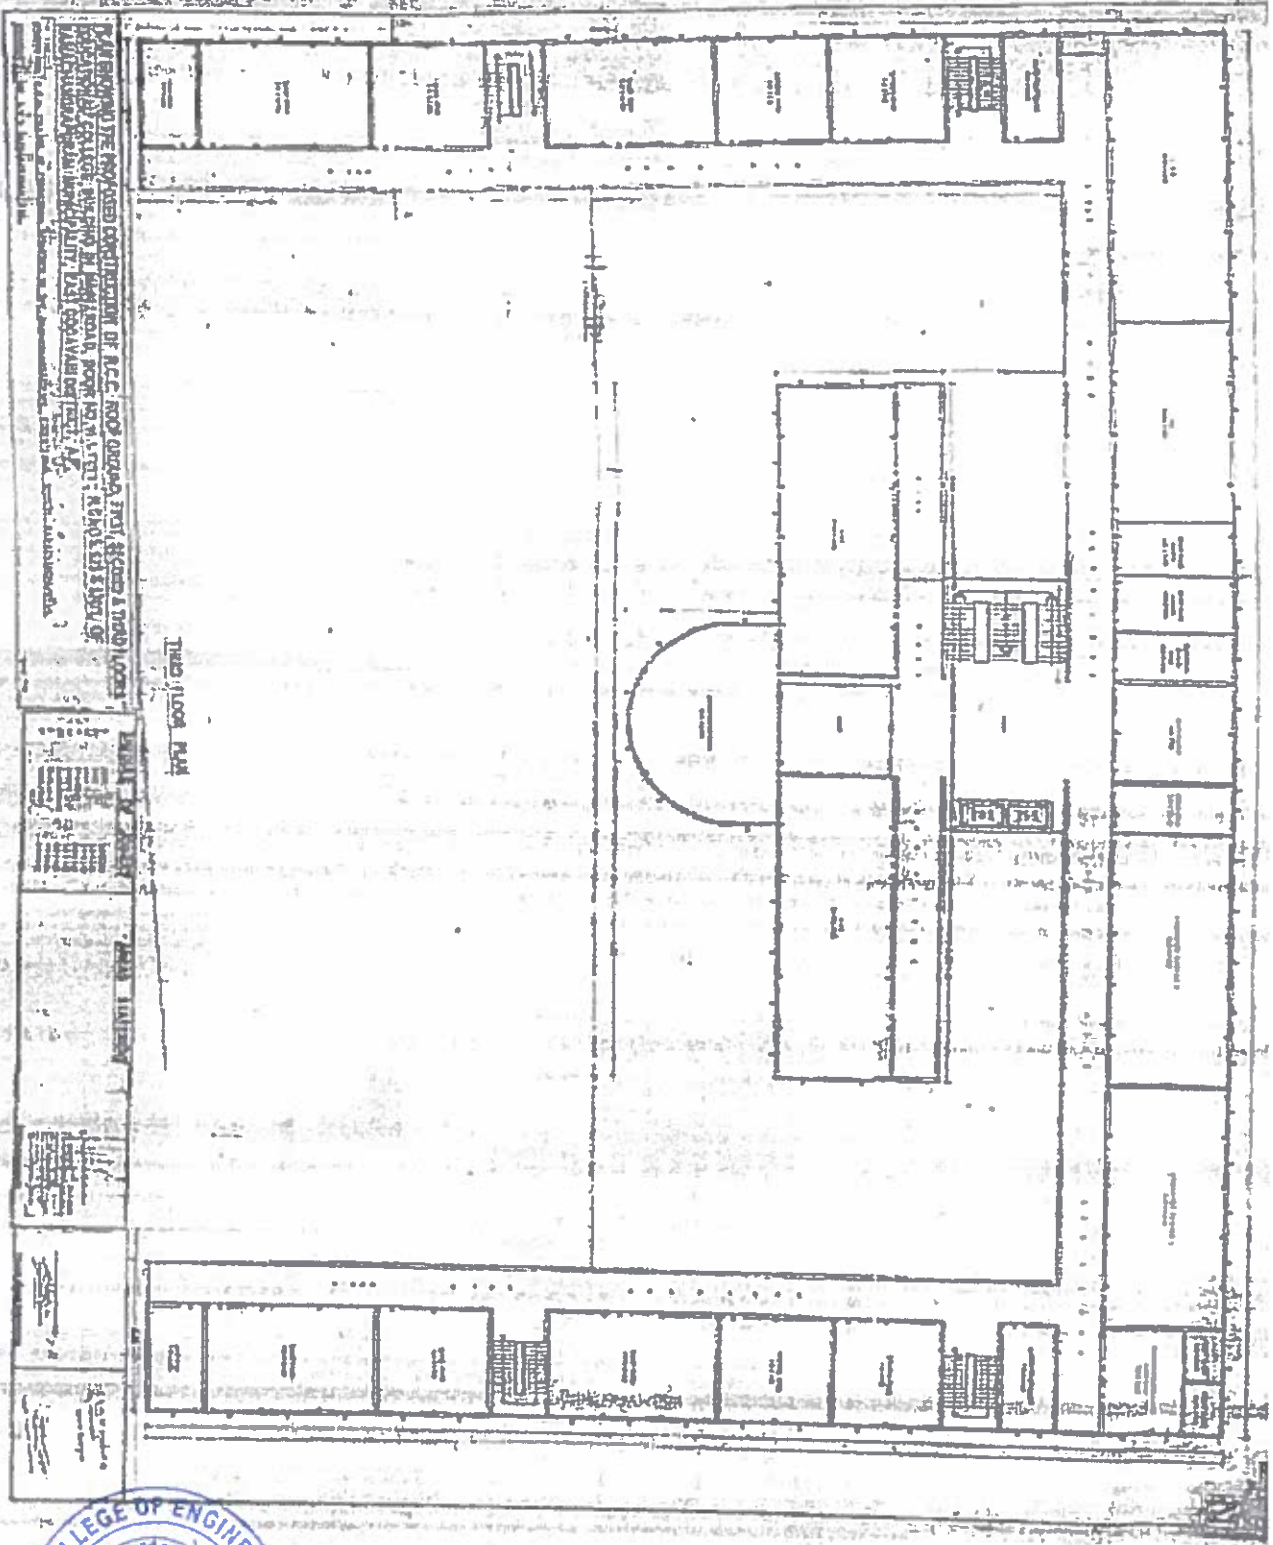

Bn
 PRINCIPAL
 V.S.M. COLLEGE OF ENGINEERING
 RAMACHANDRAPURAM